


Mondays to Sunday
From 6pm
Supervised

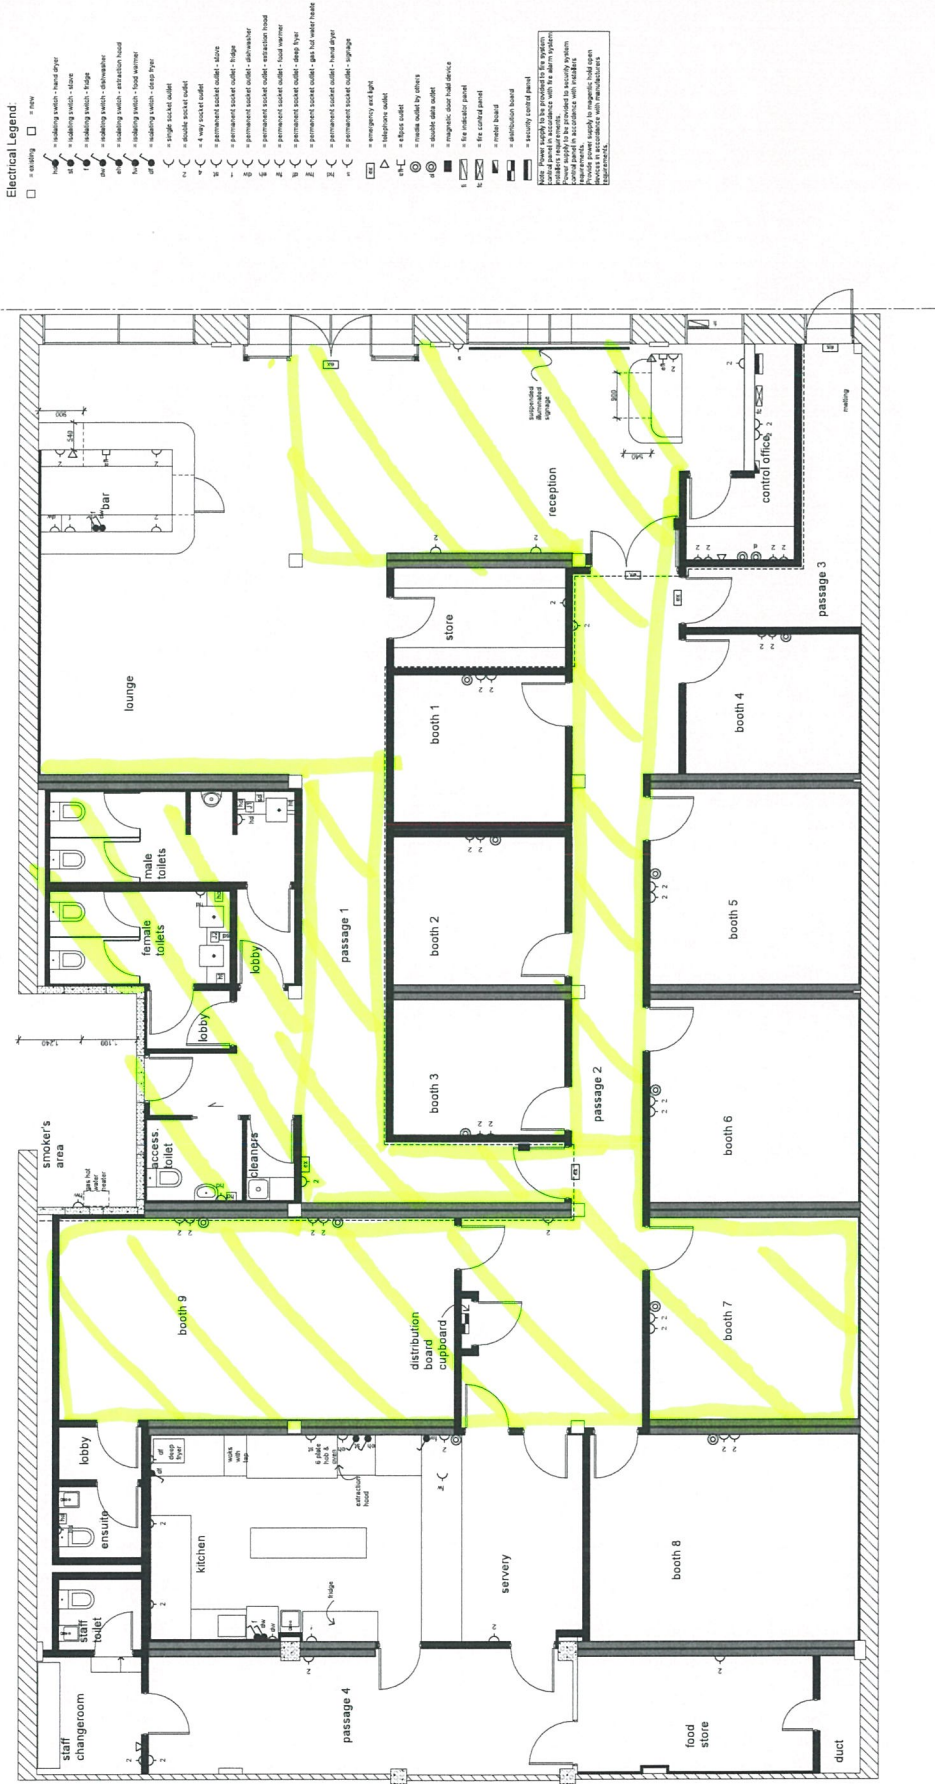

1 Electrical Plan
Scale: 1:50
note: check dimensions on site before commencing
refer to Roof Plan for roof-mounted appliance layout

Monday - Sunday 11am - 6pm
 Unsupervised.



1 Electrical Plan

note: check dimensions on site before commencing work refer to floor plan for unfootcoted appliance layout